



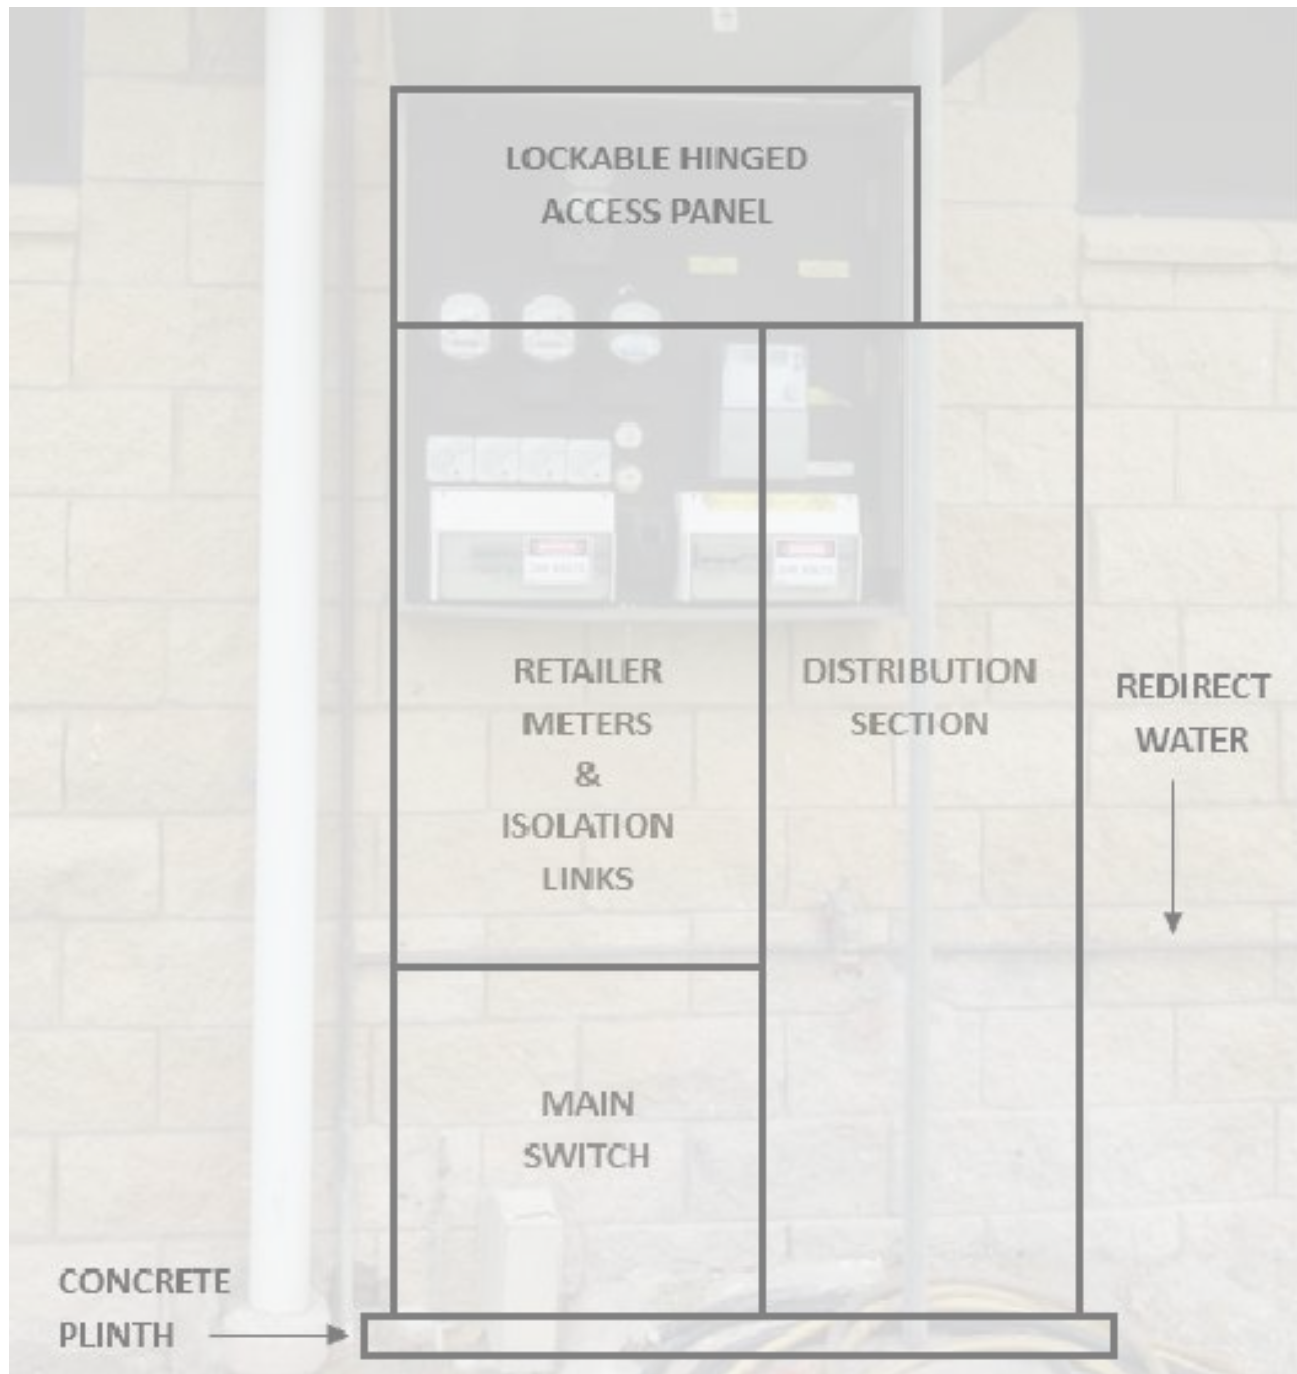


SWITCHBOARD LOCATION

NOT TO SCALE

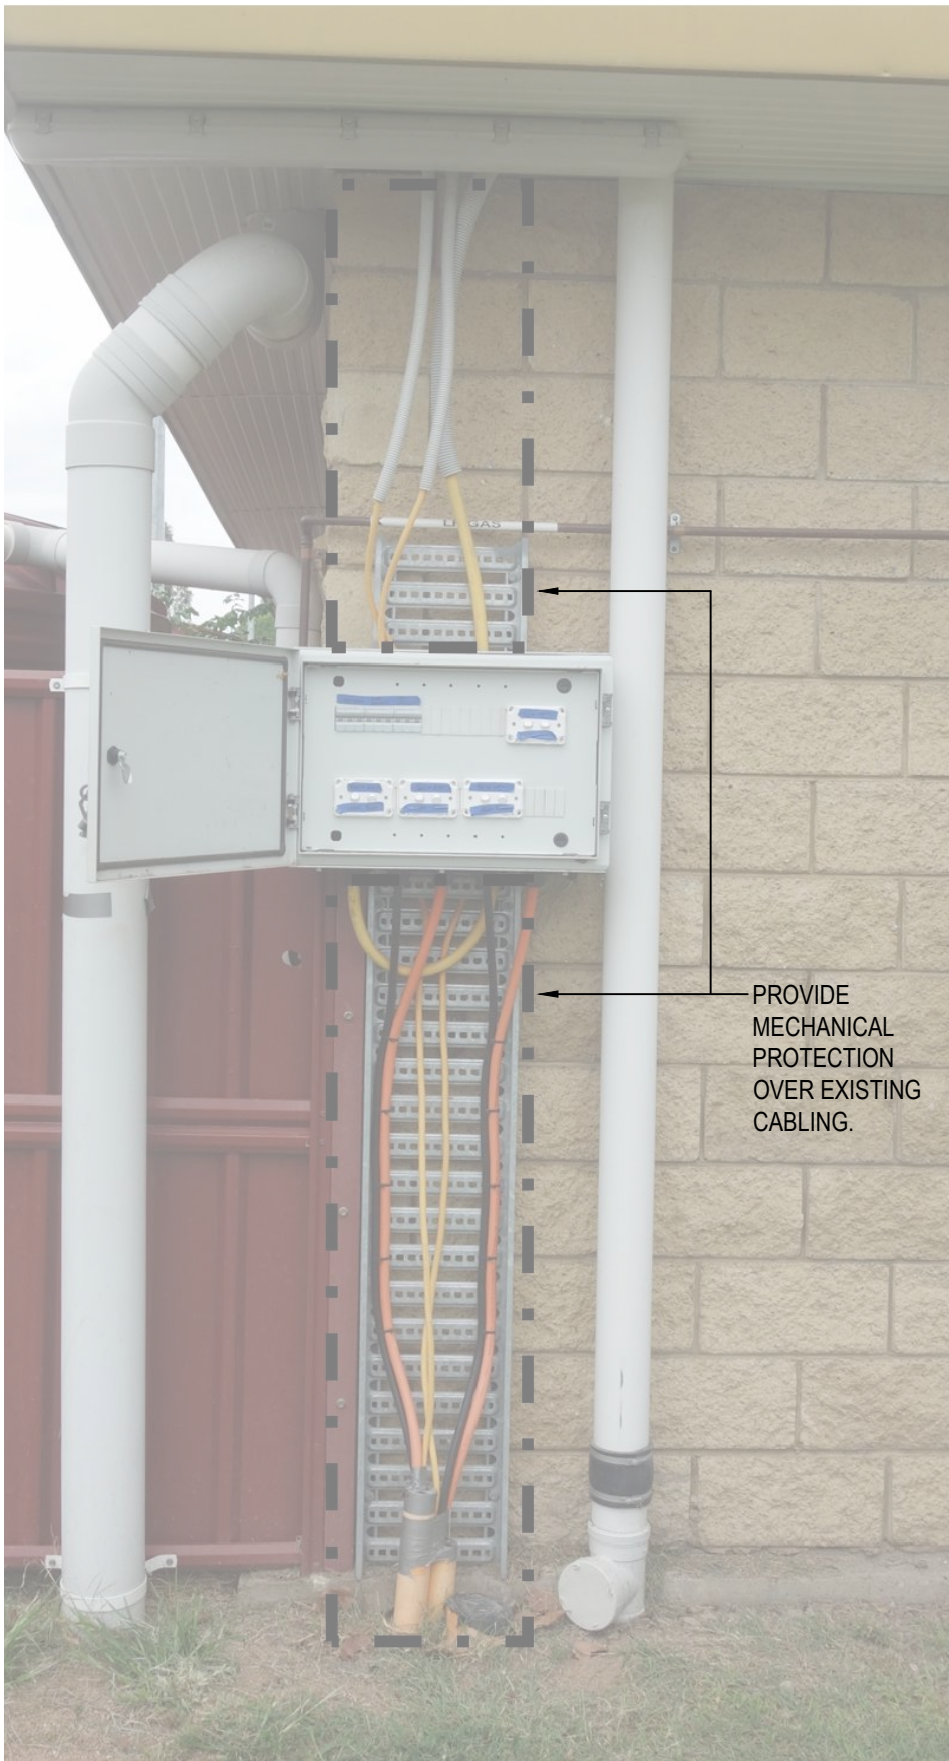


EXISTING CONTROL PANEL

NOT TO SCALE

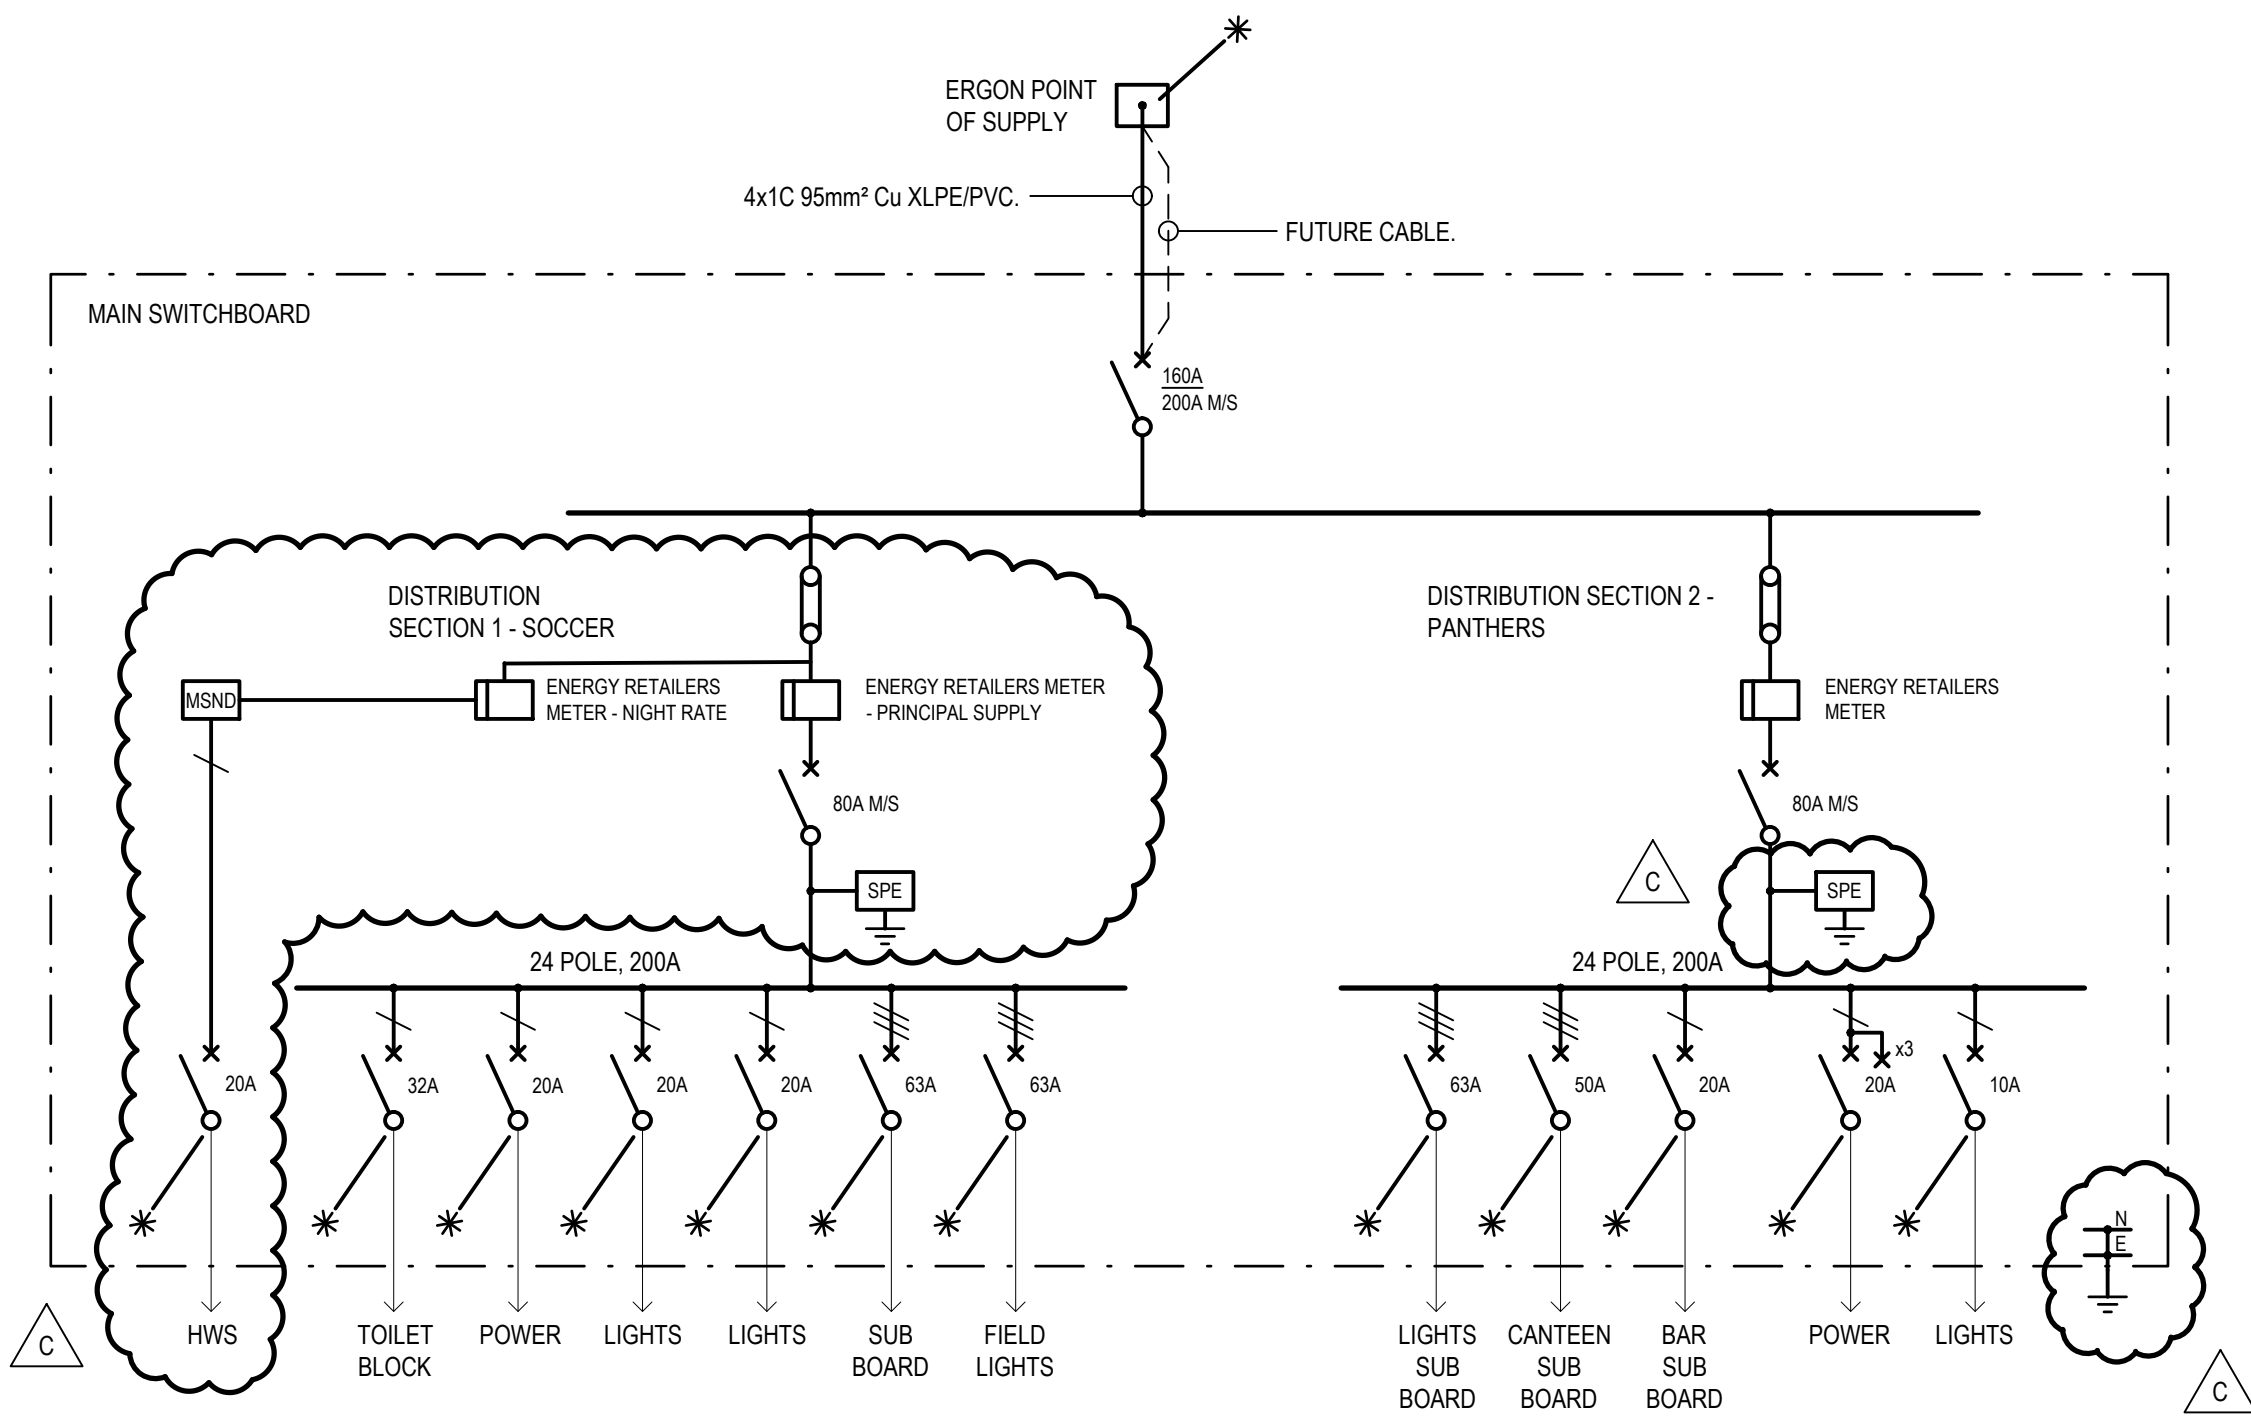

SINGLE LINE DIAGRAM

NOT TO SCALE

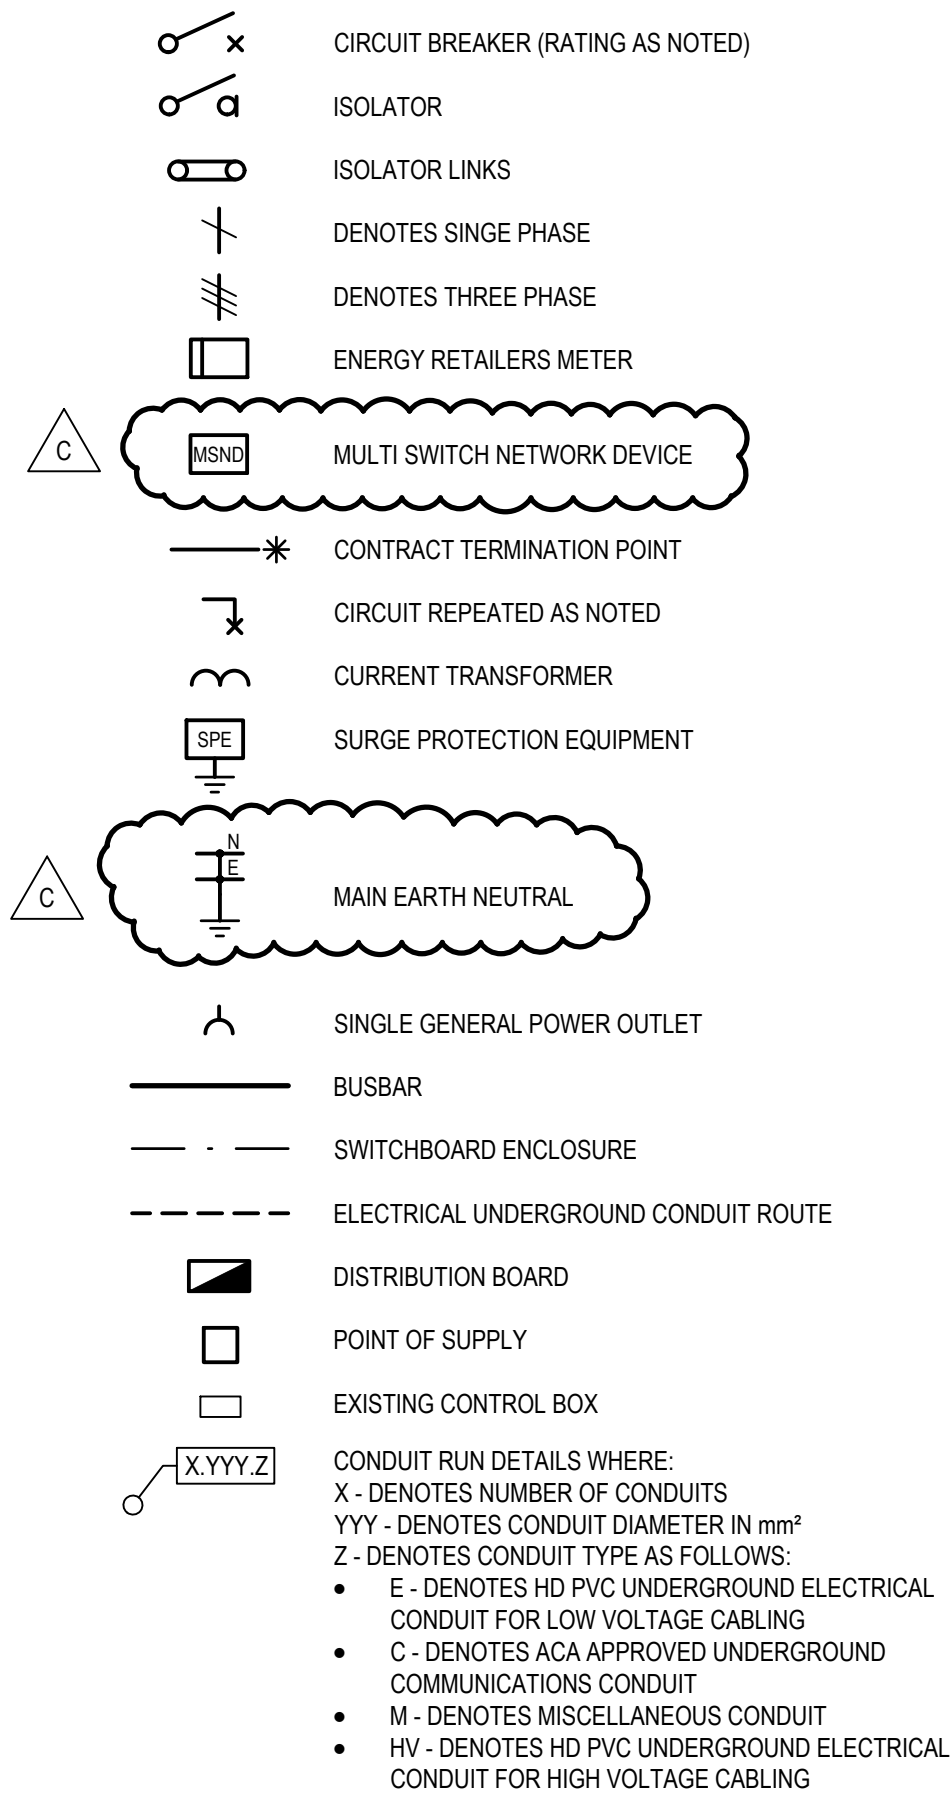

LEGEND OF SYMBOLS

NOT TO SCALE

GENERAL NOTES:
© Copyright, Anderson Consulting Engineers Pty. Ltd.
Do not scale from this drawing. Take measurements on site prior to commencing work.

NOTES: (N)
1. ALL CIRCUITS THREE PHASE UNLESS OTHERWISE NOTED.

17/05/24	C	SINGLE LINE DIAGRAM ALTERED	G.A.
08/05/24	B	CABLE SIZING ALTERED	G.A.
23/04/24	A	TENDER ISSUE	G.A.

Date	Rev	Details	App
------	-----	---------	-----

Client:
BANANA SHIRE COUNCIL

ANDERSON
CONSULTING ENGINEERS

43 Denison Street, Rockhampton, Q. 4700
P.O. Box 27, Rockhampton, Q. 4700
Phone: (07) 4927 2077
Email: admin@andersonce.com.au
ACN: 112 066 529 ABN: 98 112 066 529

Project:
RAINBOW STREET, BILOELA
SPORTS PRECINCT

Title:
ELECTRICAL SERVICES
SINGLE LINE DIAGRAM.
SWITCHBOARD LAYOUT.
LEGEND.

Drawing No:	23165R-E002	Rev:	C
Drawn:	VMC	Designed:	G.A.
Scale @ A1:	NTS	Approved:	G.A.
Date:	APRIL 24	No:	2
		Of:	2

TENDER ISSUE