


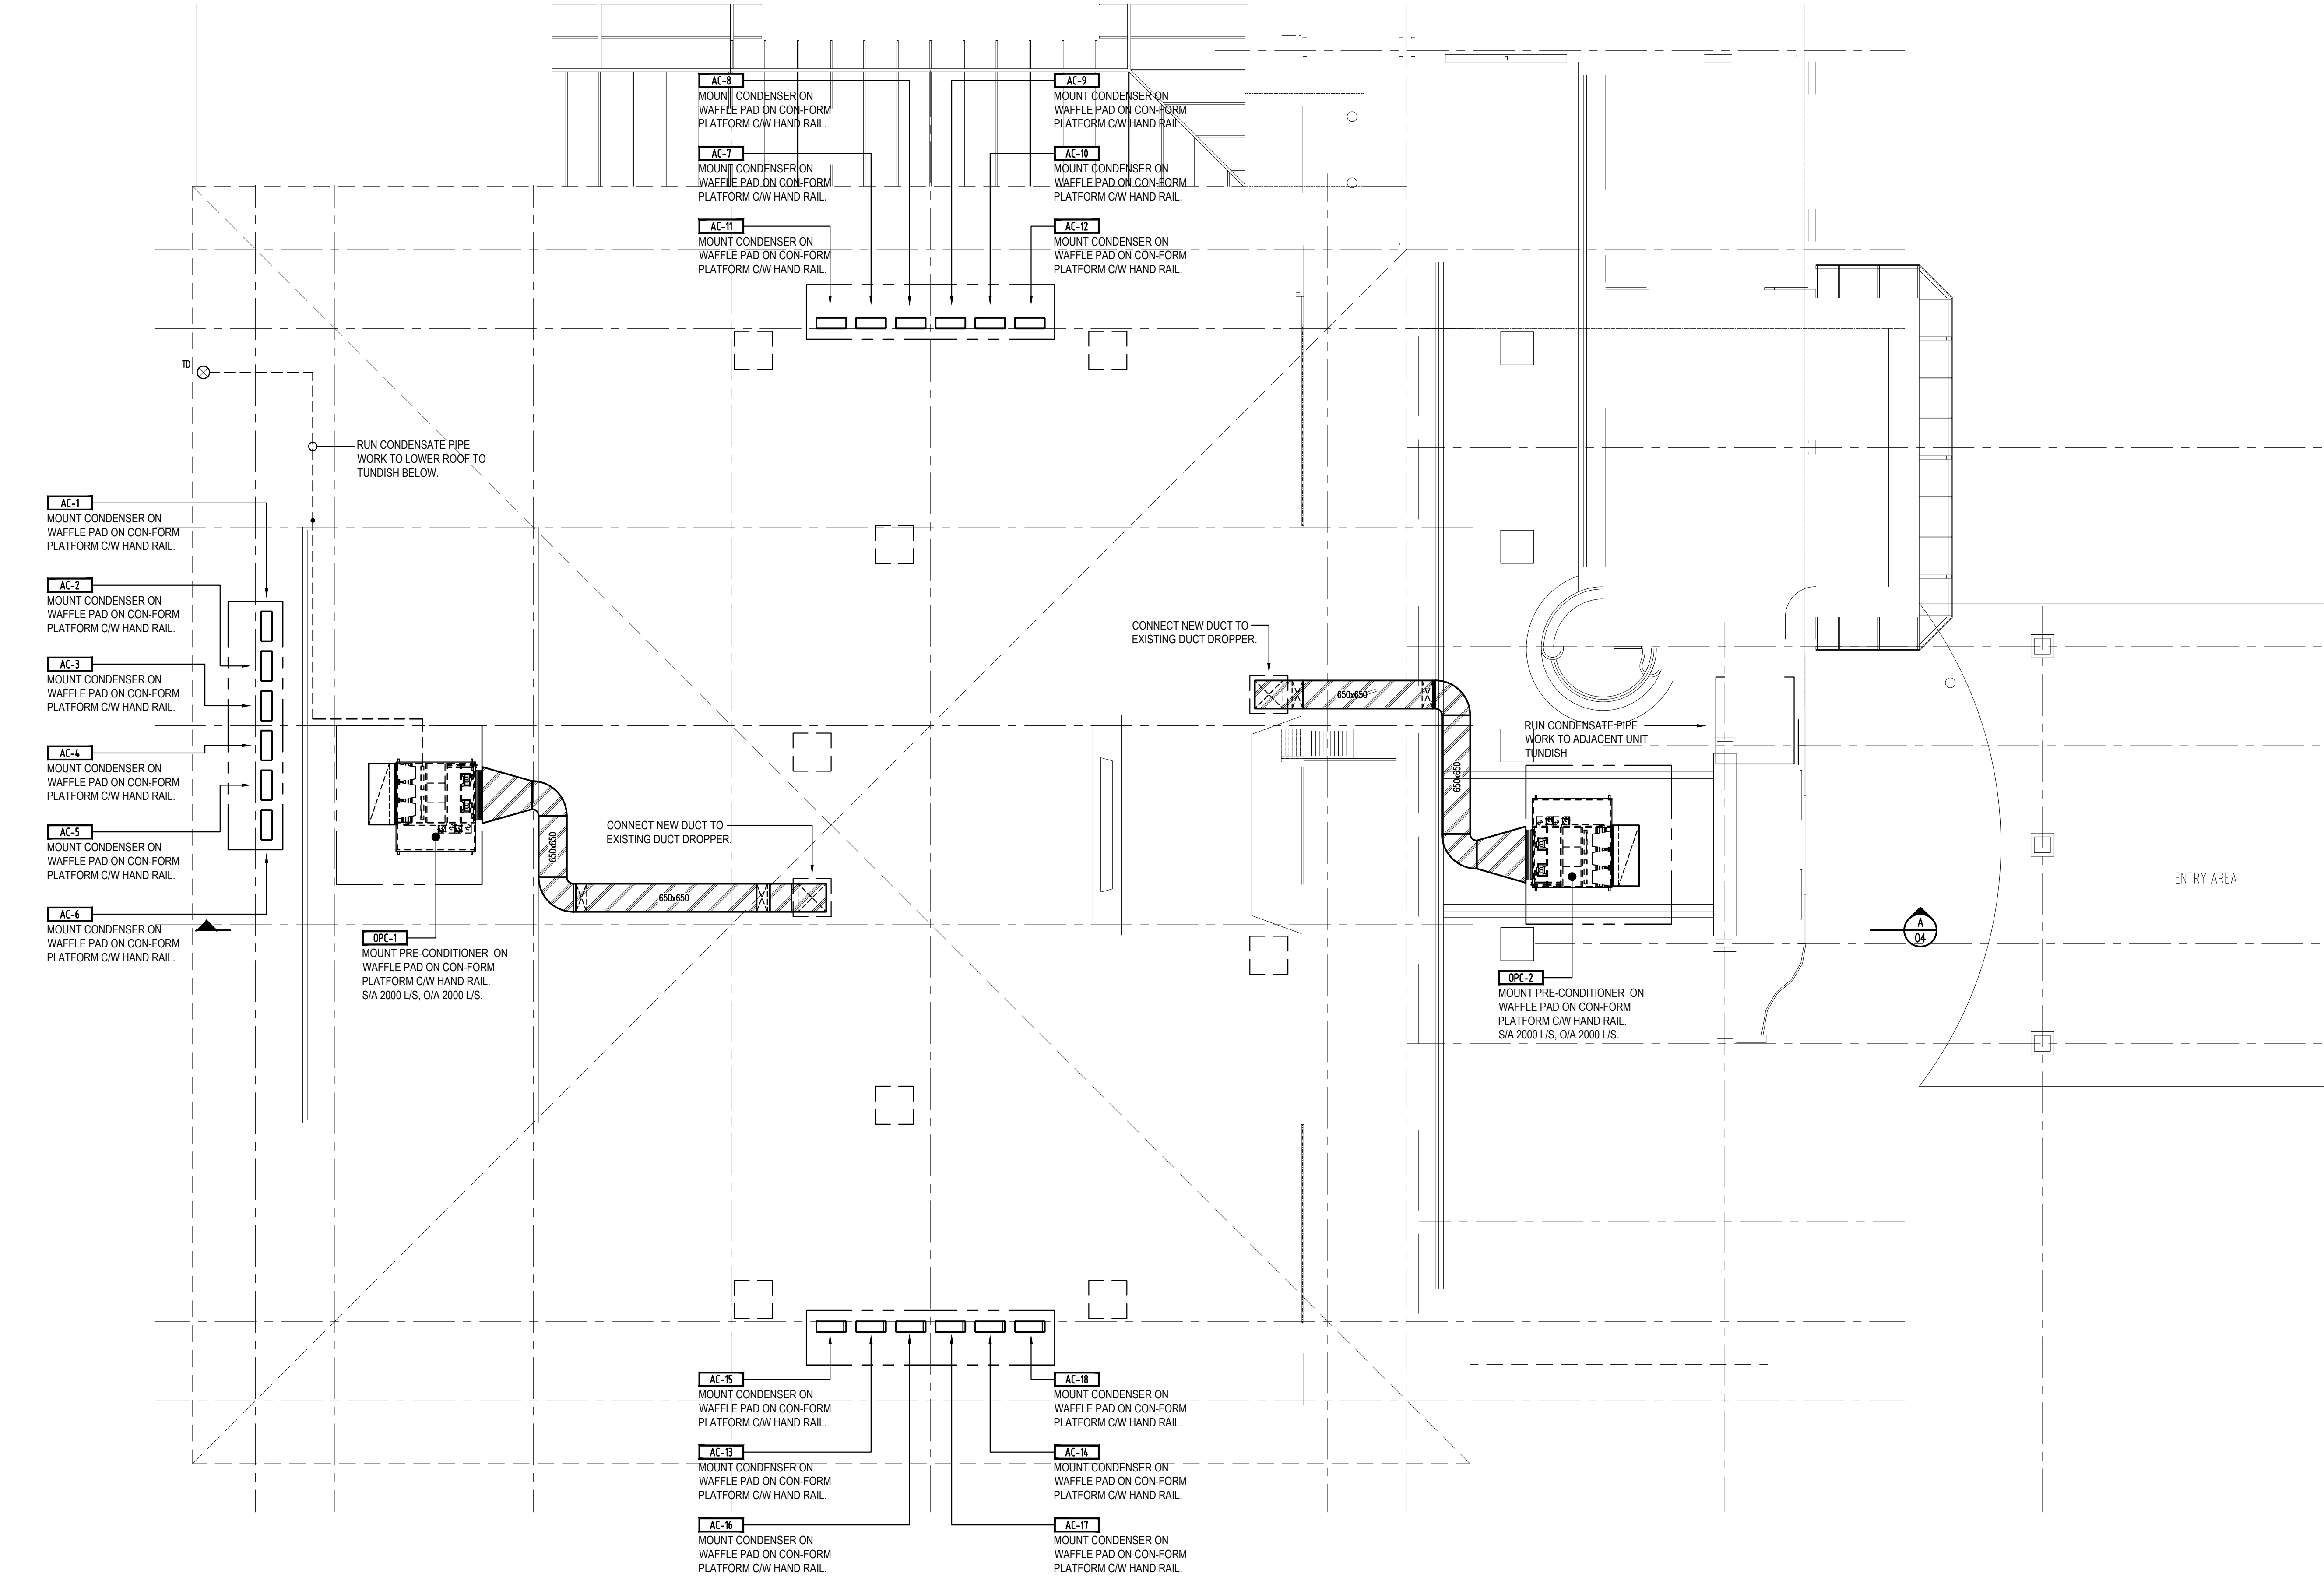

NEW AIR CONDITIONING AND VENTILATION LAYOUT
SCALE - 1:100

GENERAL NOTES:
© Copyright, Anderson Consulting Engineers Pty. Ltd.
Do not scale from this drawing. Take measurements on site prior to commencing work.

20/06/24	A	TENDER ISSUE	D.W.
Date	Rev	Details	App
Client:			
			

ANDERSON
CONSULTING ENGINEERS
43 Denison Street, Rockhampton, Q. 4700
P.O. Box 27, Rockhampton, Q. 4700
Phone: (07) 4927 2077
Email: admin@andersonce.com.au
ACN: 112 066 529 ABN: 98 112 066 529

Project:
**BILOELA CIVIC CENTRE
REFURBISHMENT**

Title:
**MECHANICAL SERVICES
NEW AIR CONDITIONING AND
VENTILATION LAYOUT.
PLAN - ROOF LEVEL**

Drawing No: 23165-M003		Rev: A
Drawn: VMC	Designed: D.W.	
Scale @ A1: 1:100	Approved: D.W.	
Date: MARCH 2024	No: 3	Of: 4

TENDER ISSUE